
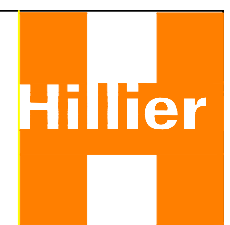


Drawing Legend

- Vehicular Traffic Flow
- Pedestrian Walkway Path
- Construction Parking
- ROCK CONSTRUCTION ENTRANCE
- LIMIT OF DISTURBANCE
- STANDARD SILT FENCE
- PROTECTIVE FENCE
- BUILDING
- FENCE
- FIRE HYDRANT
- SUPER SILT FENCE
- STORM SEWER WITH INLET
- SANITARY SEWER
- WATER LINE WITH VALVE
- CHILLED WATER LINE
- STEAM LINE
- ELECTRIC LINE
- TELECOMMUNICATION LINE
- ELECTRICAL CONDUIT FOR SITE LIGHTING WITH HANDHOLE
- STORM SEWER PIPING

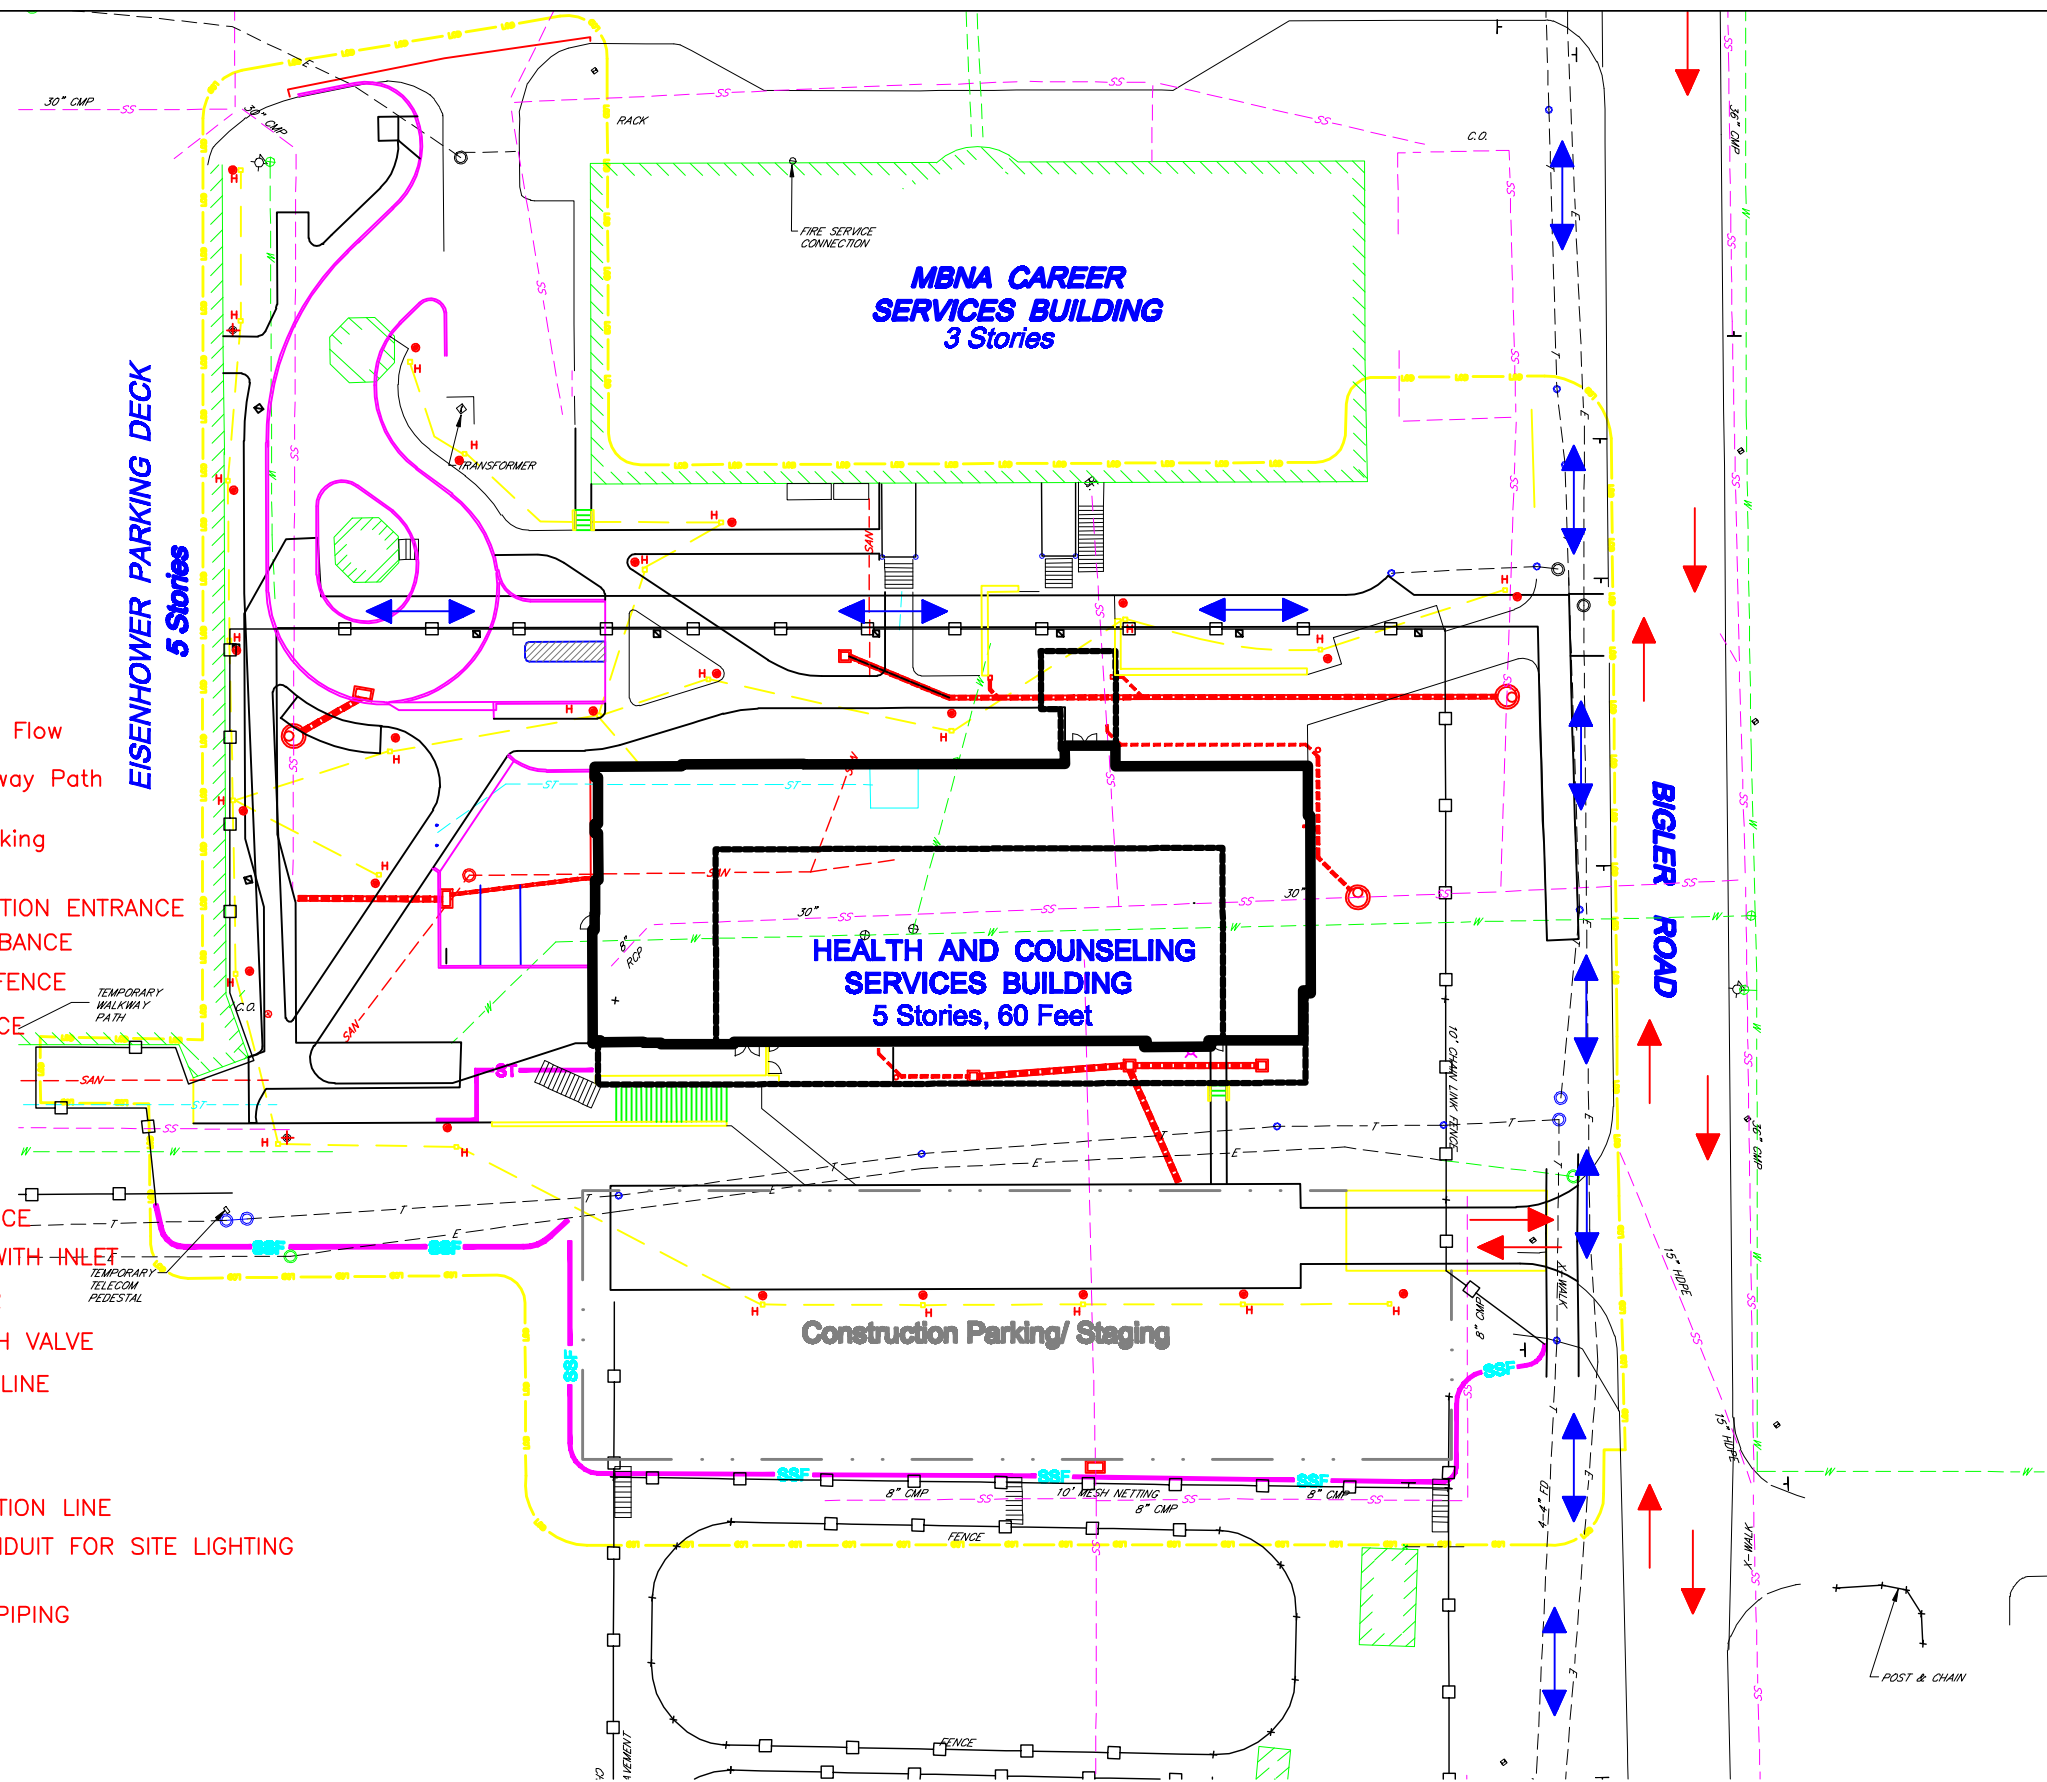

Adam Finley
Penn State
Construction Mgmt.
Prepared for:
Dr. Michael Horman
10/5/06

Appendix A

Project
University Health
and Counseling
Services Building
Penn State University
University Park,
Pennsylvania

SITE PLAN

Scale	Author	Project No.
1"=50'	Adam Finley	
Sheet No.		

Scale = N.T.S.