

 

APPENDIX C | Lighting Plans


KEY:

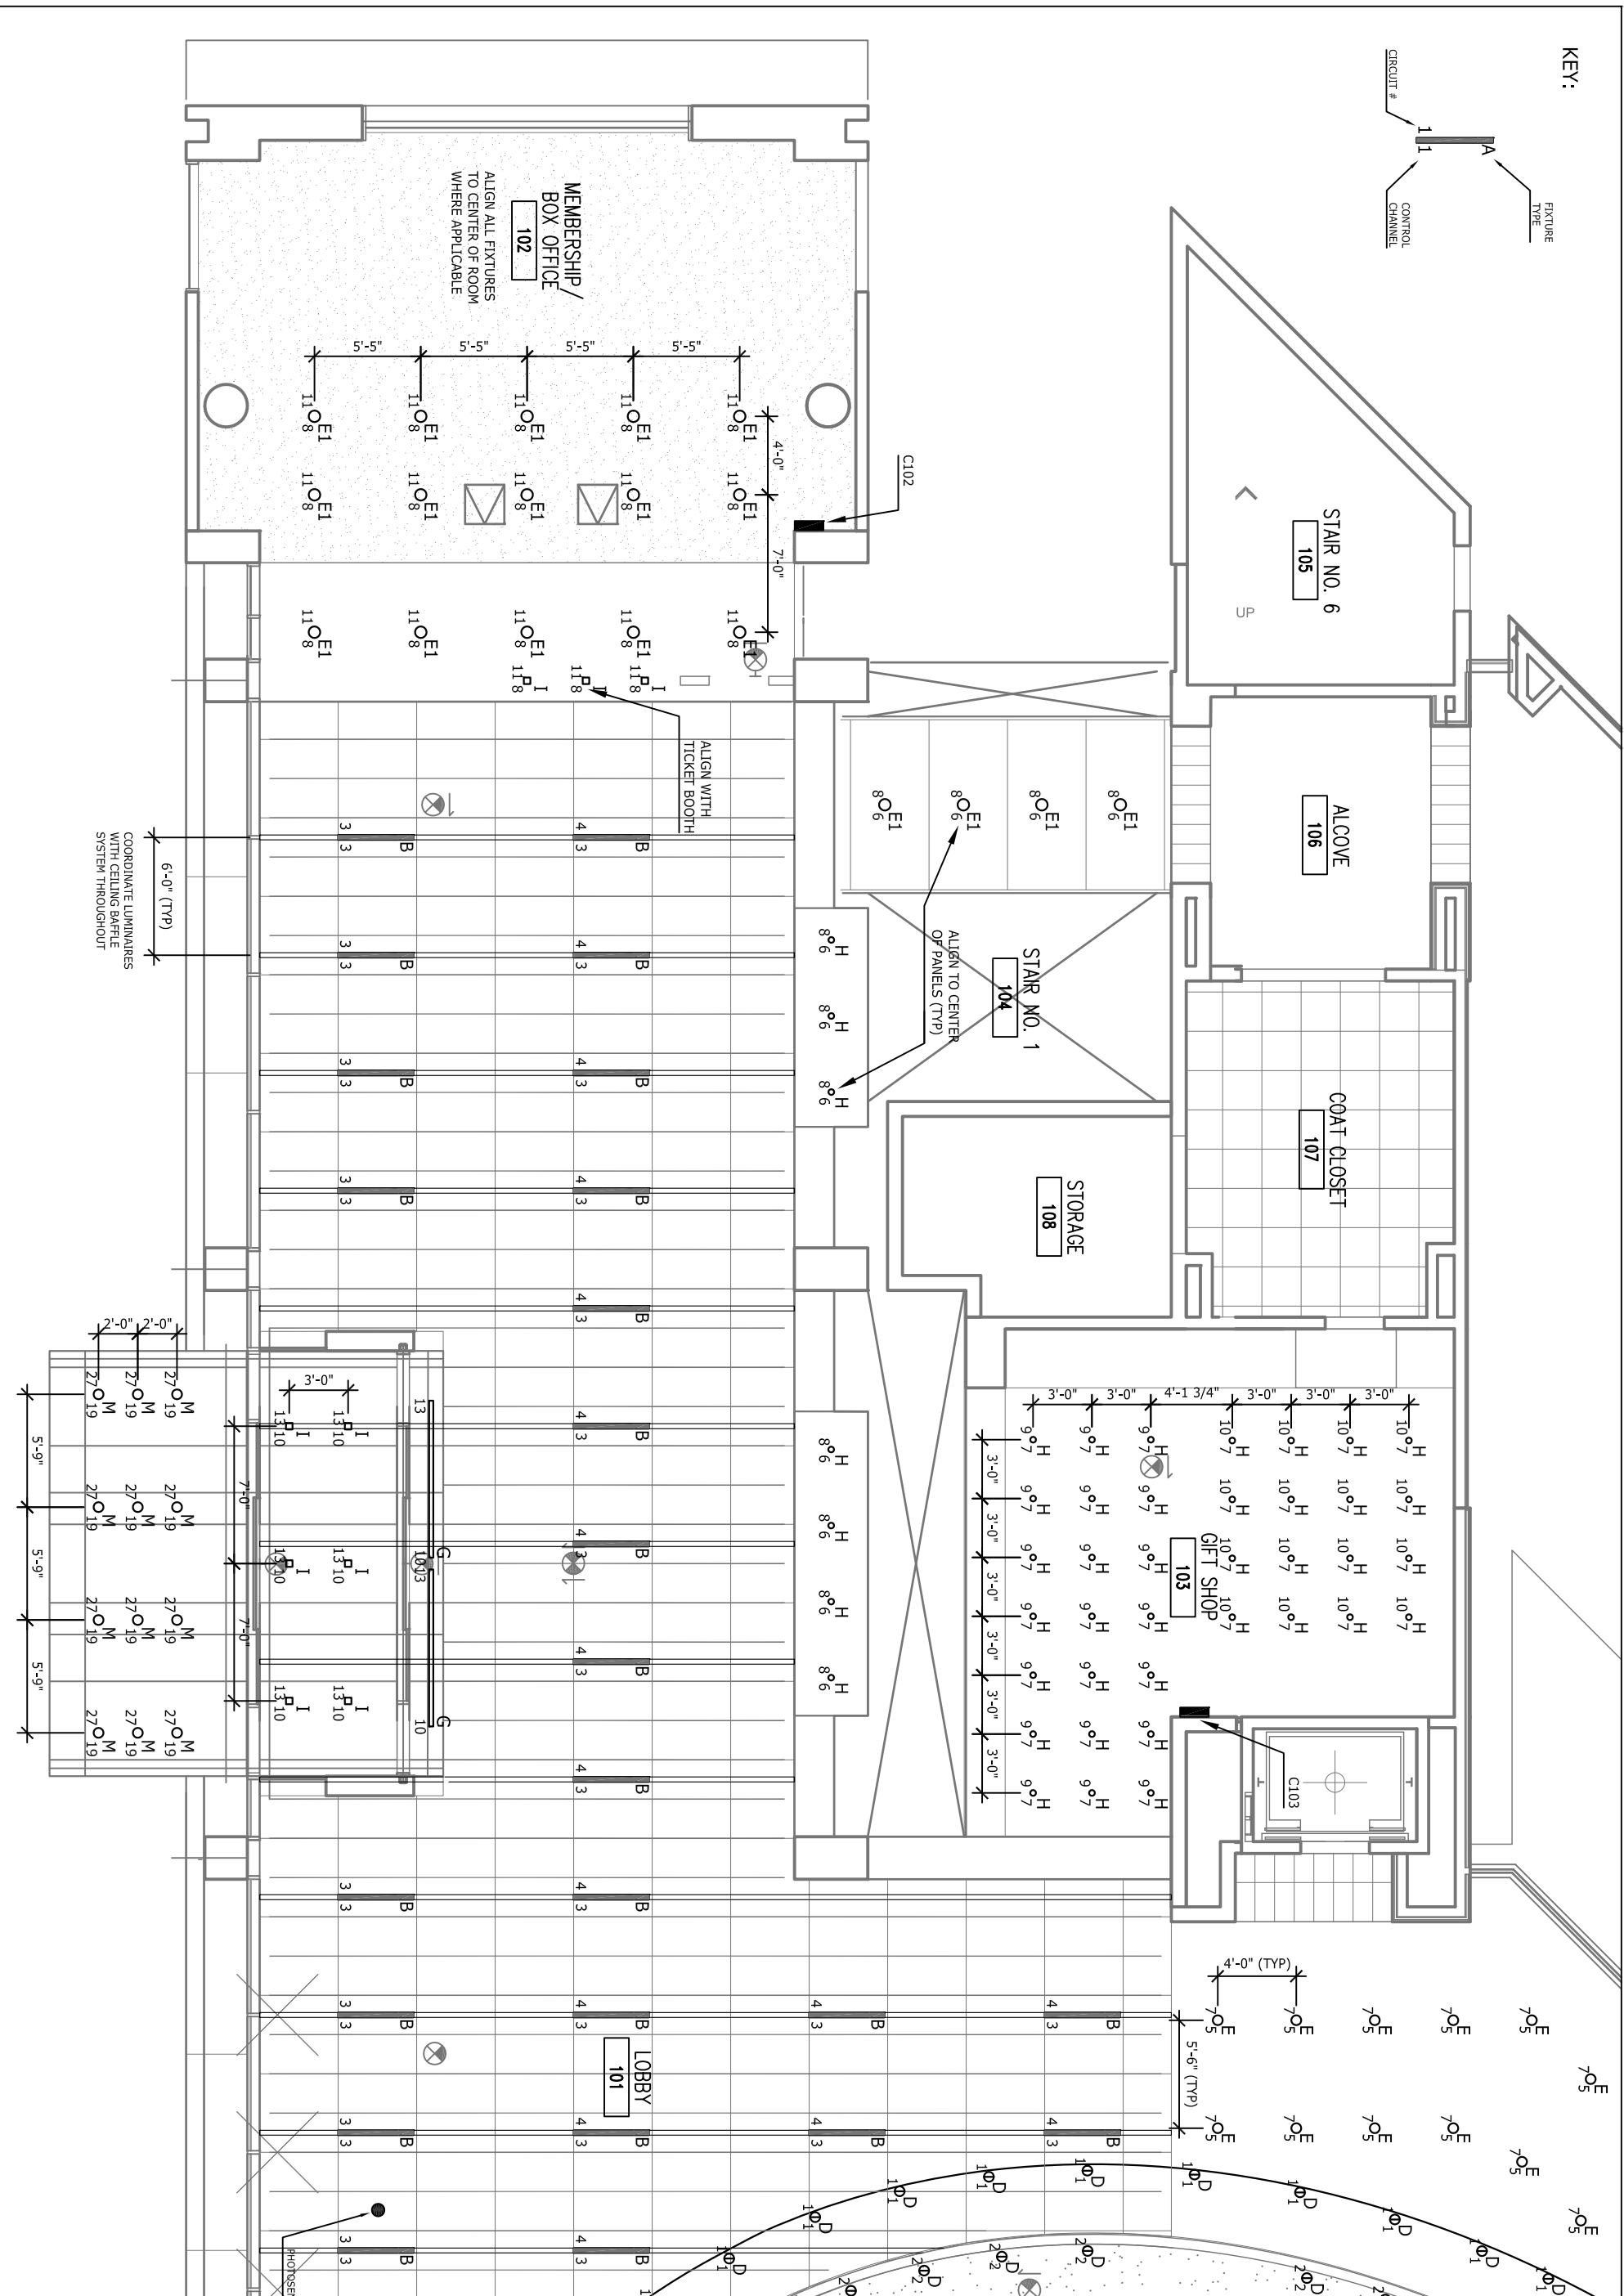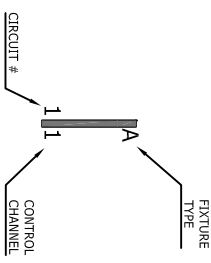



MICHAEL P. ROYER
 THE PENNSYLVANIA STATE UNIVERSITY
 ARCHITECTURAL ENGINEERING SENIOR THESIS
 PRESENTED APRIL 16, 2008

FIRST LEVEL LIGHTING PLAN
 THE AUGUST WILSON CENTER FOR AFRICAN AMERICAN CULTURE
 SCALE: 1/8" = 1'
 PAGE: 1 OF 2



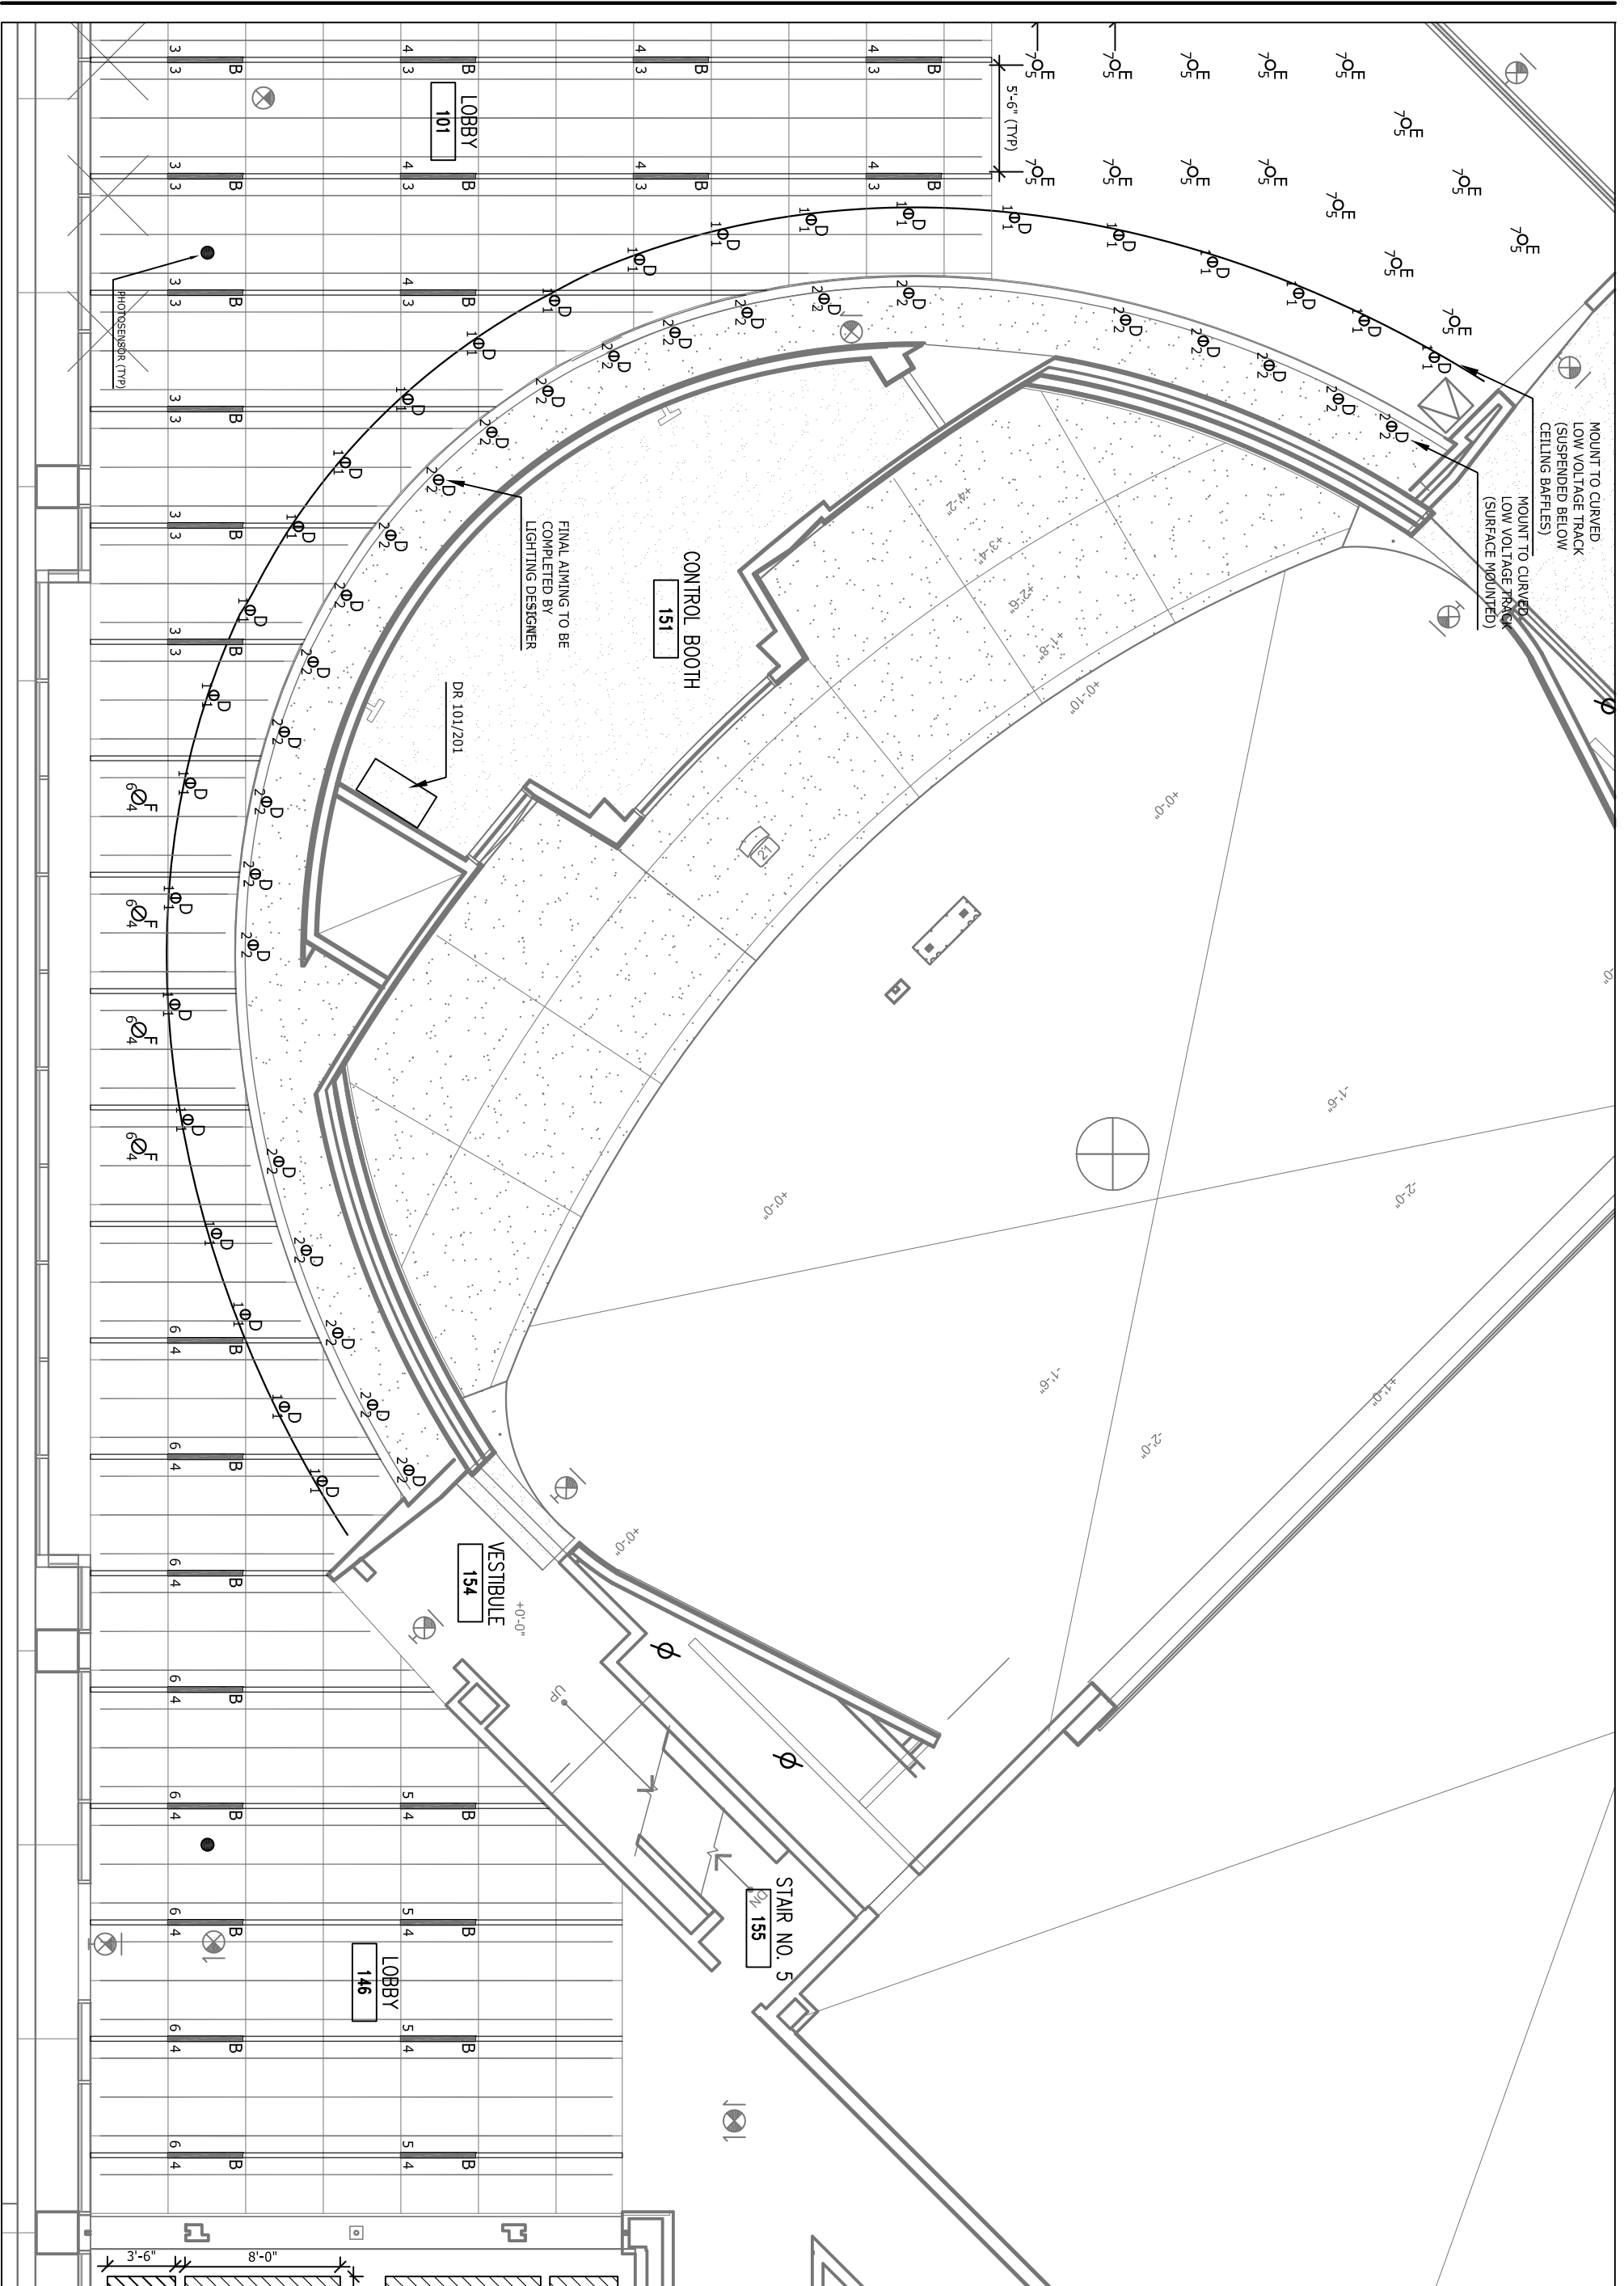



KEY:

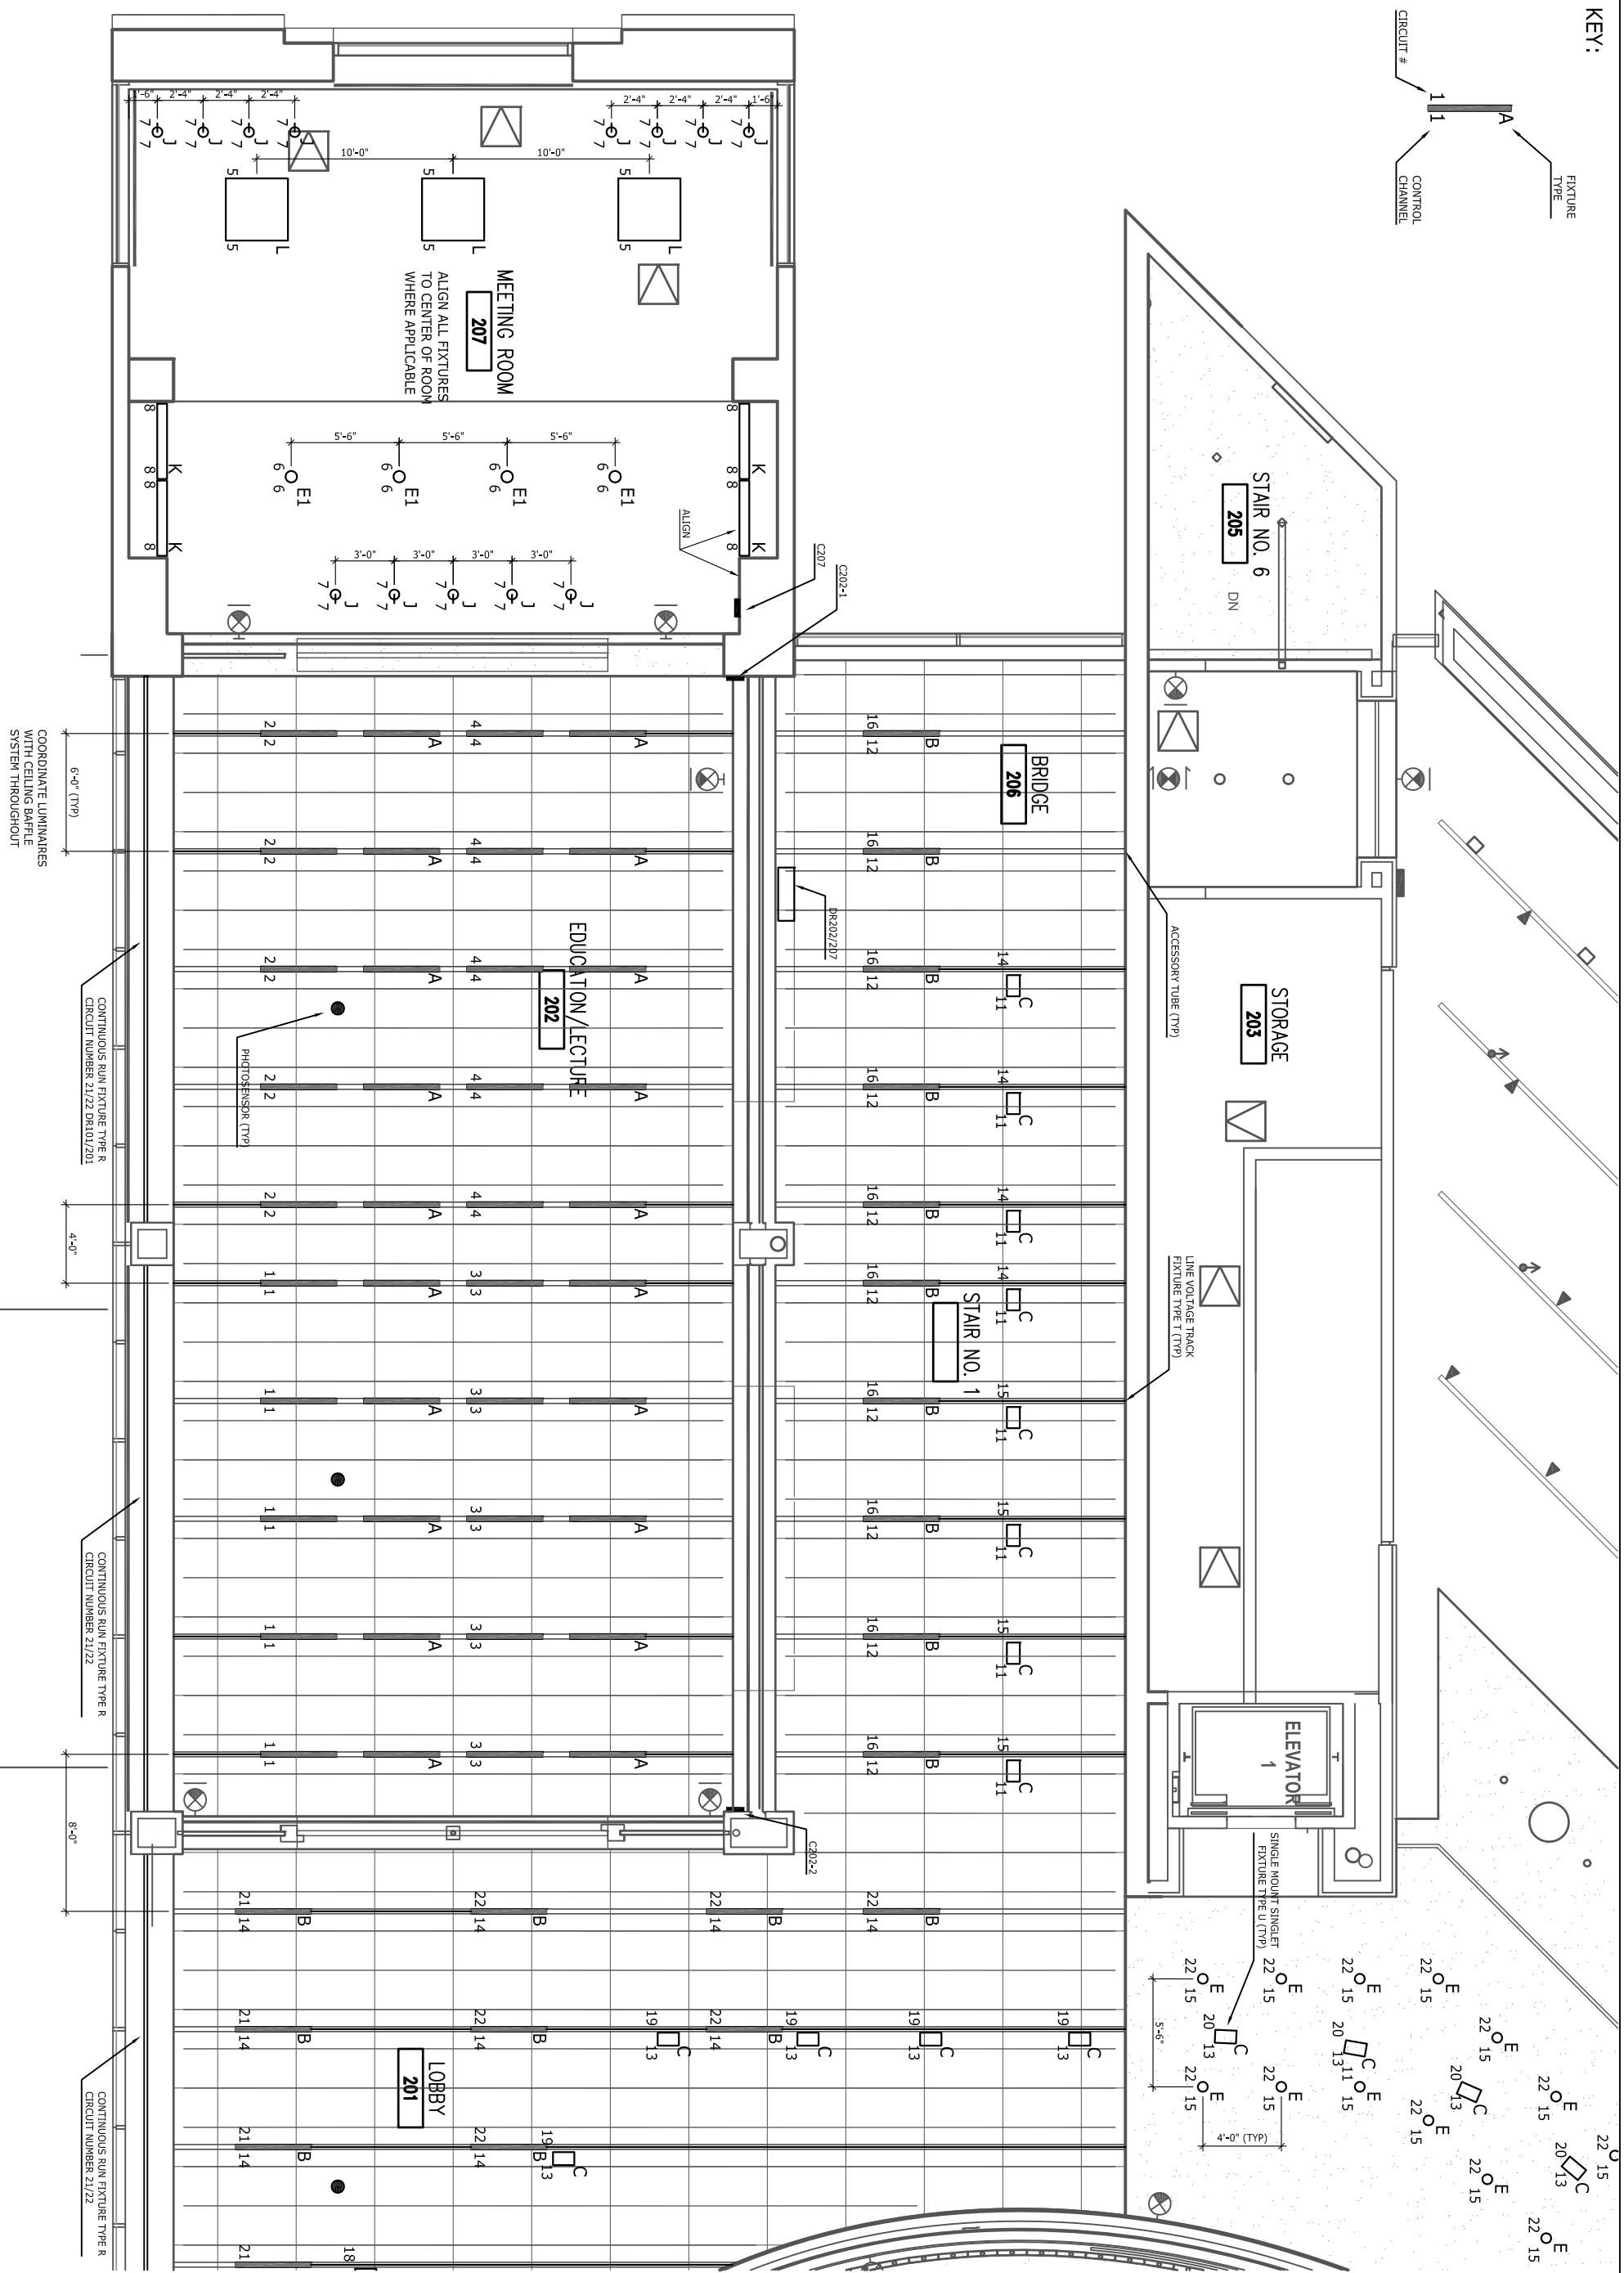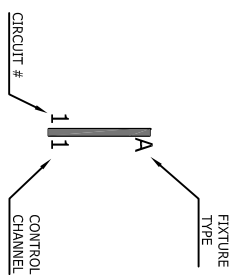

MICHAEL P. ROYER
 THE PENNSYLVANIA STATE UNIVERSITY
 ARCHITECTURAL ENGINEERING SENIOR THESIS
 PRESENTED APRIL 16, 2008

 SECOND LEVEL LIGHTING PLAN
 THE AUGUST WILSON CENTER FOR AFRICAN AMERICAN CULTURE
 SCALE: 1/8" = 1'
 PAGE: 1 OF 2



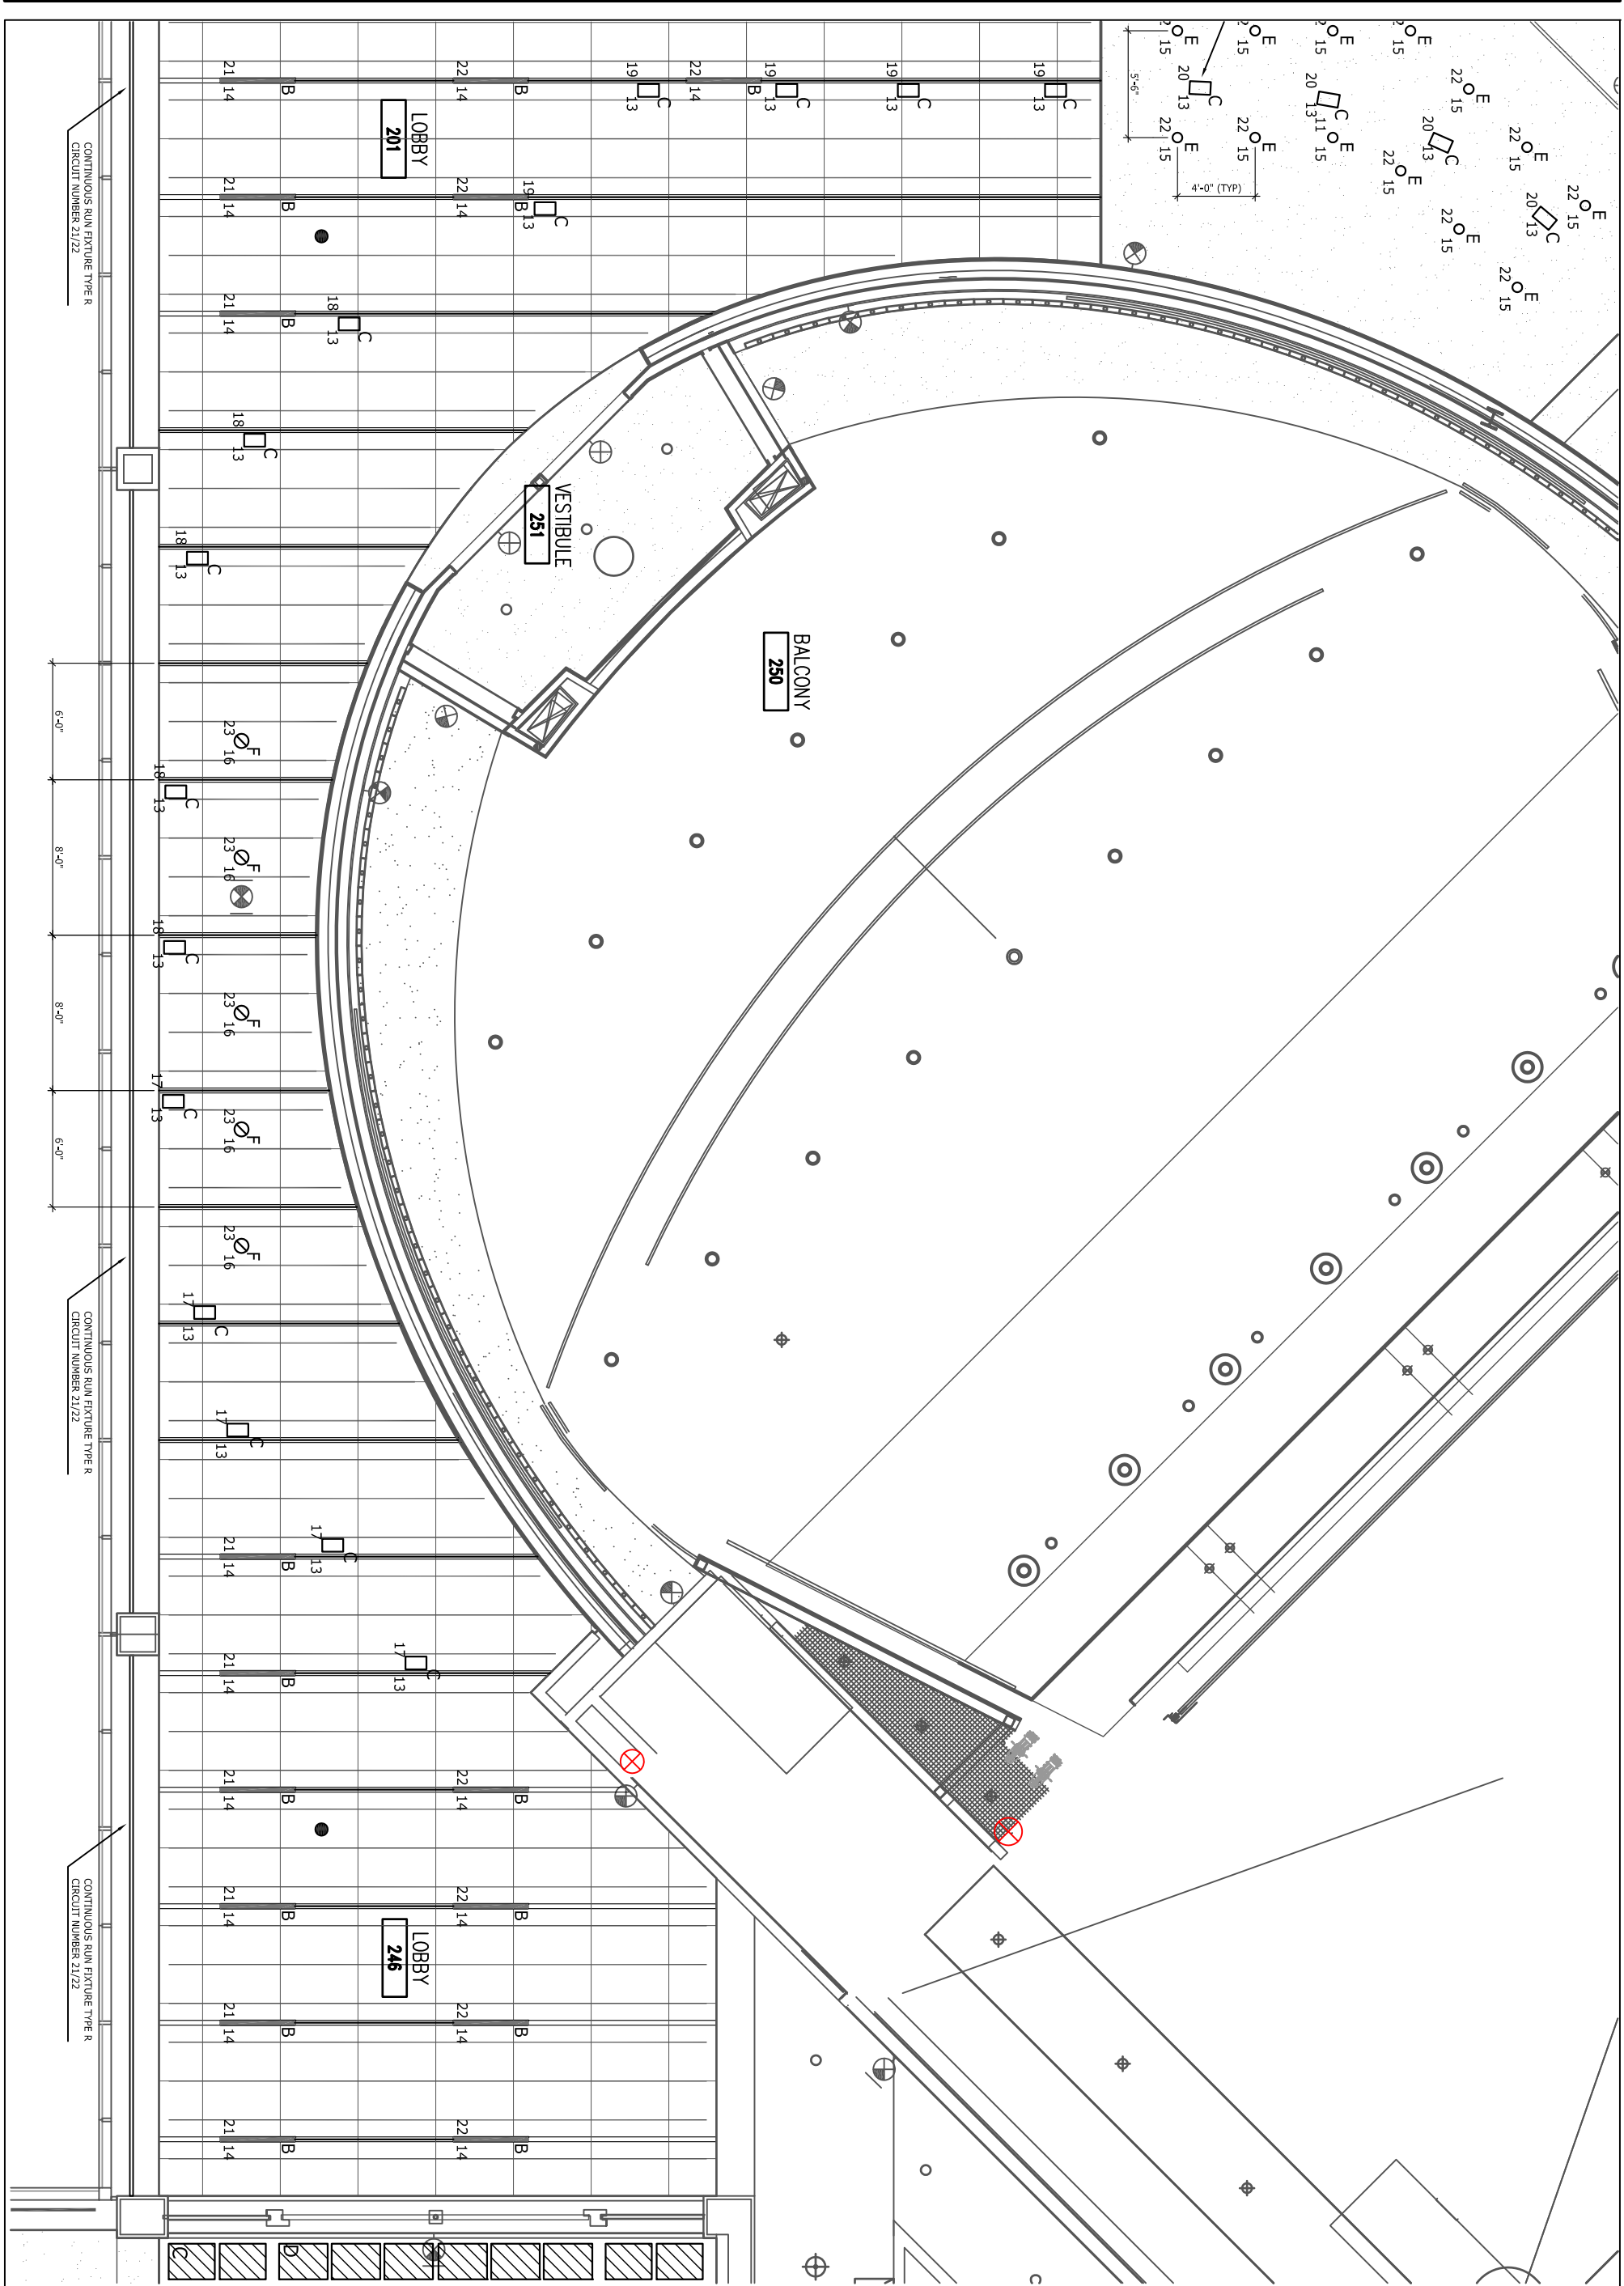

MICHAEL P. ROYER
 THE PENNSYLVANIA STATE UNIVERSITY
 ARCHITECTURAL ENGINEERING SENIOR THESIS
 PRESENTED APRIL 16, 2008

SECOND LEVEL LIGHTING PLAN
 THE AUGUST WILSON CENTER FOR AFRICAN AMERICAN CULTURE
 SCALE: 1/8" = 1'
 PAGE: 2 OF 2

