

 

APPENDIX F | Electrical Plans


KEY:

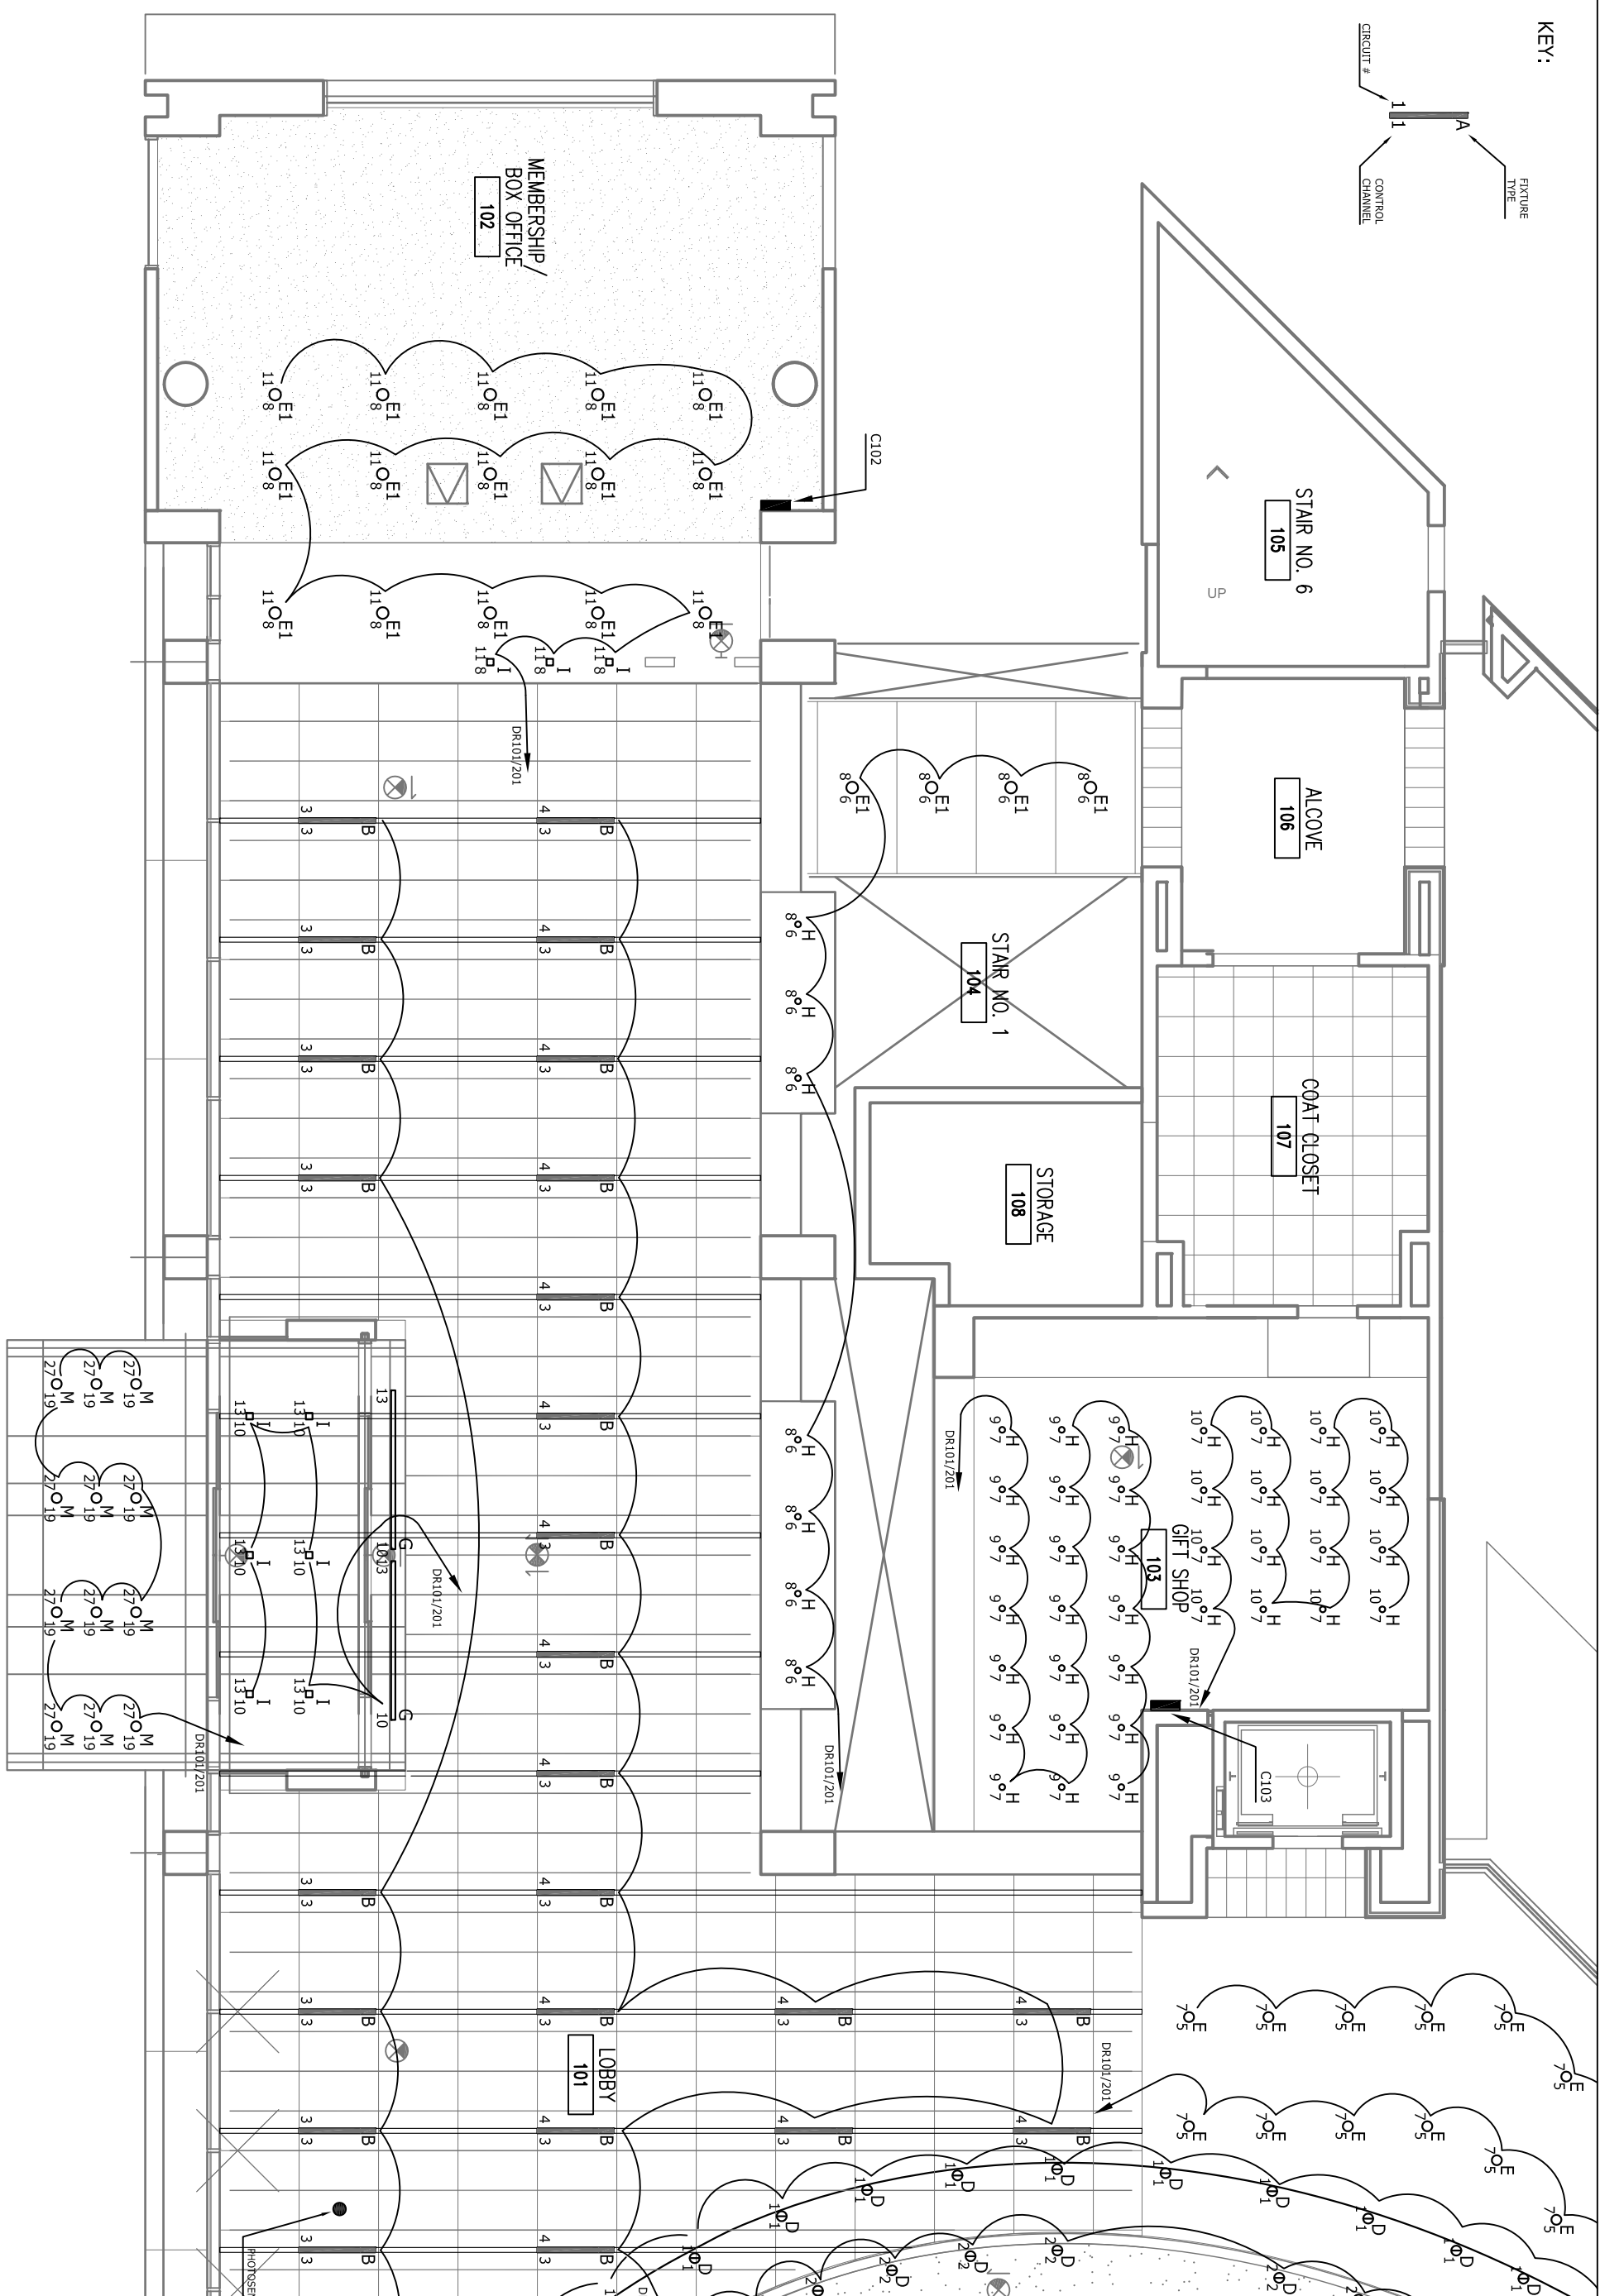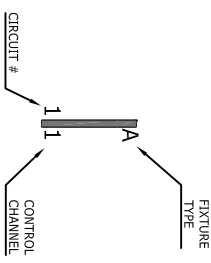


MICHAEL P. ROYER
 THE PENNSYLVANIA STATE UNIVERSITY
 ARCHITECTURAL ENGINEERING SENIOR THESIS
 PRESENTED APRIL 16, 2008

FIRST LEVEL ELECTRICAL PLAN
 THE AUGUST WILSON CENTER FOR AFRICAN AMERICAN CULTURE
 SCALE: 1/8" = 1'
 PAGE: 1 OF 2





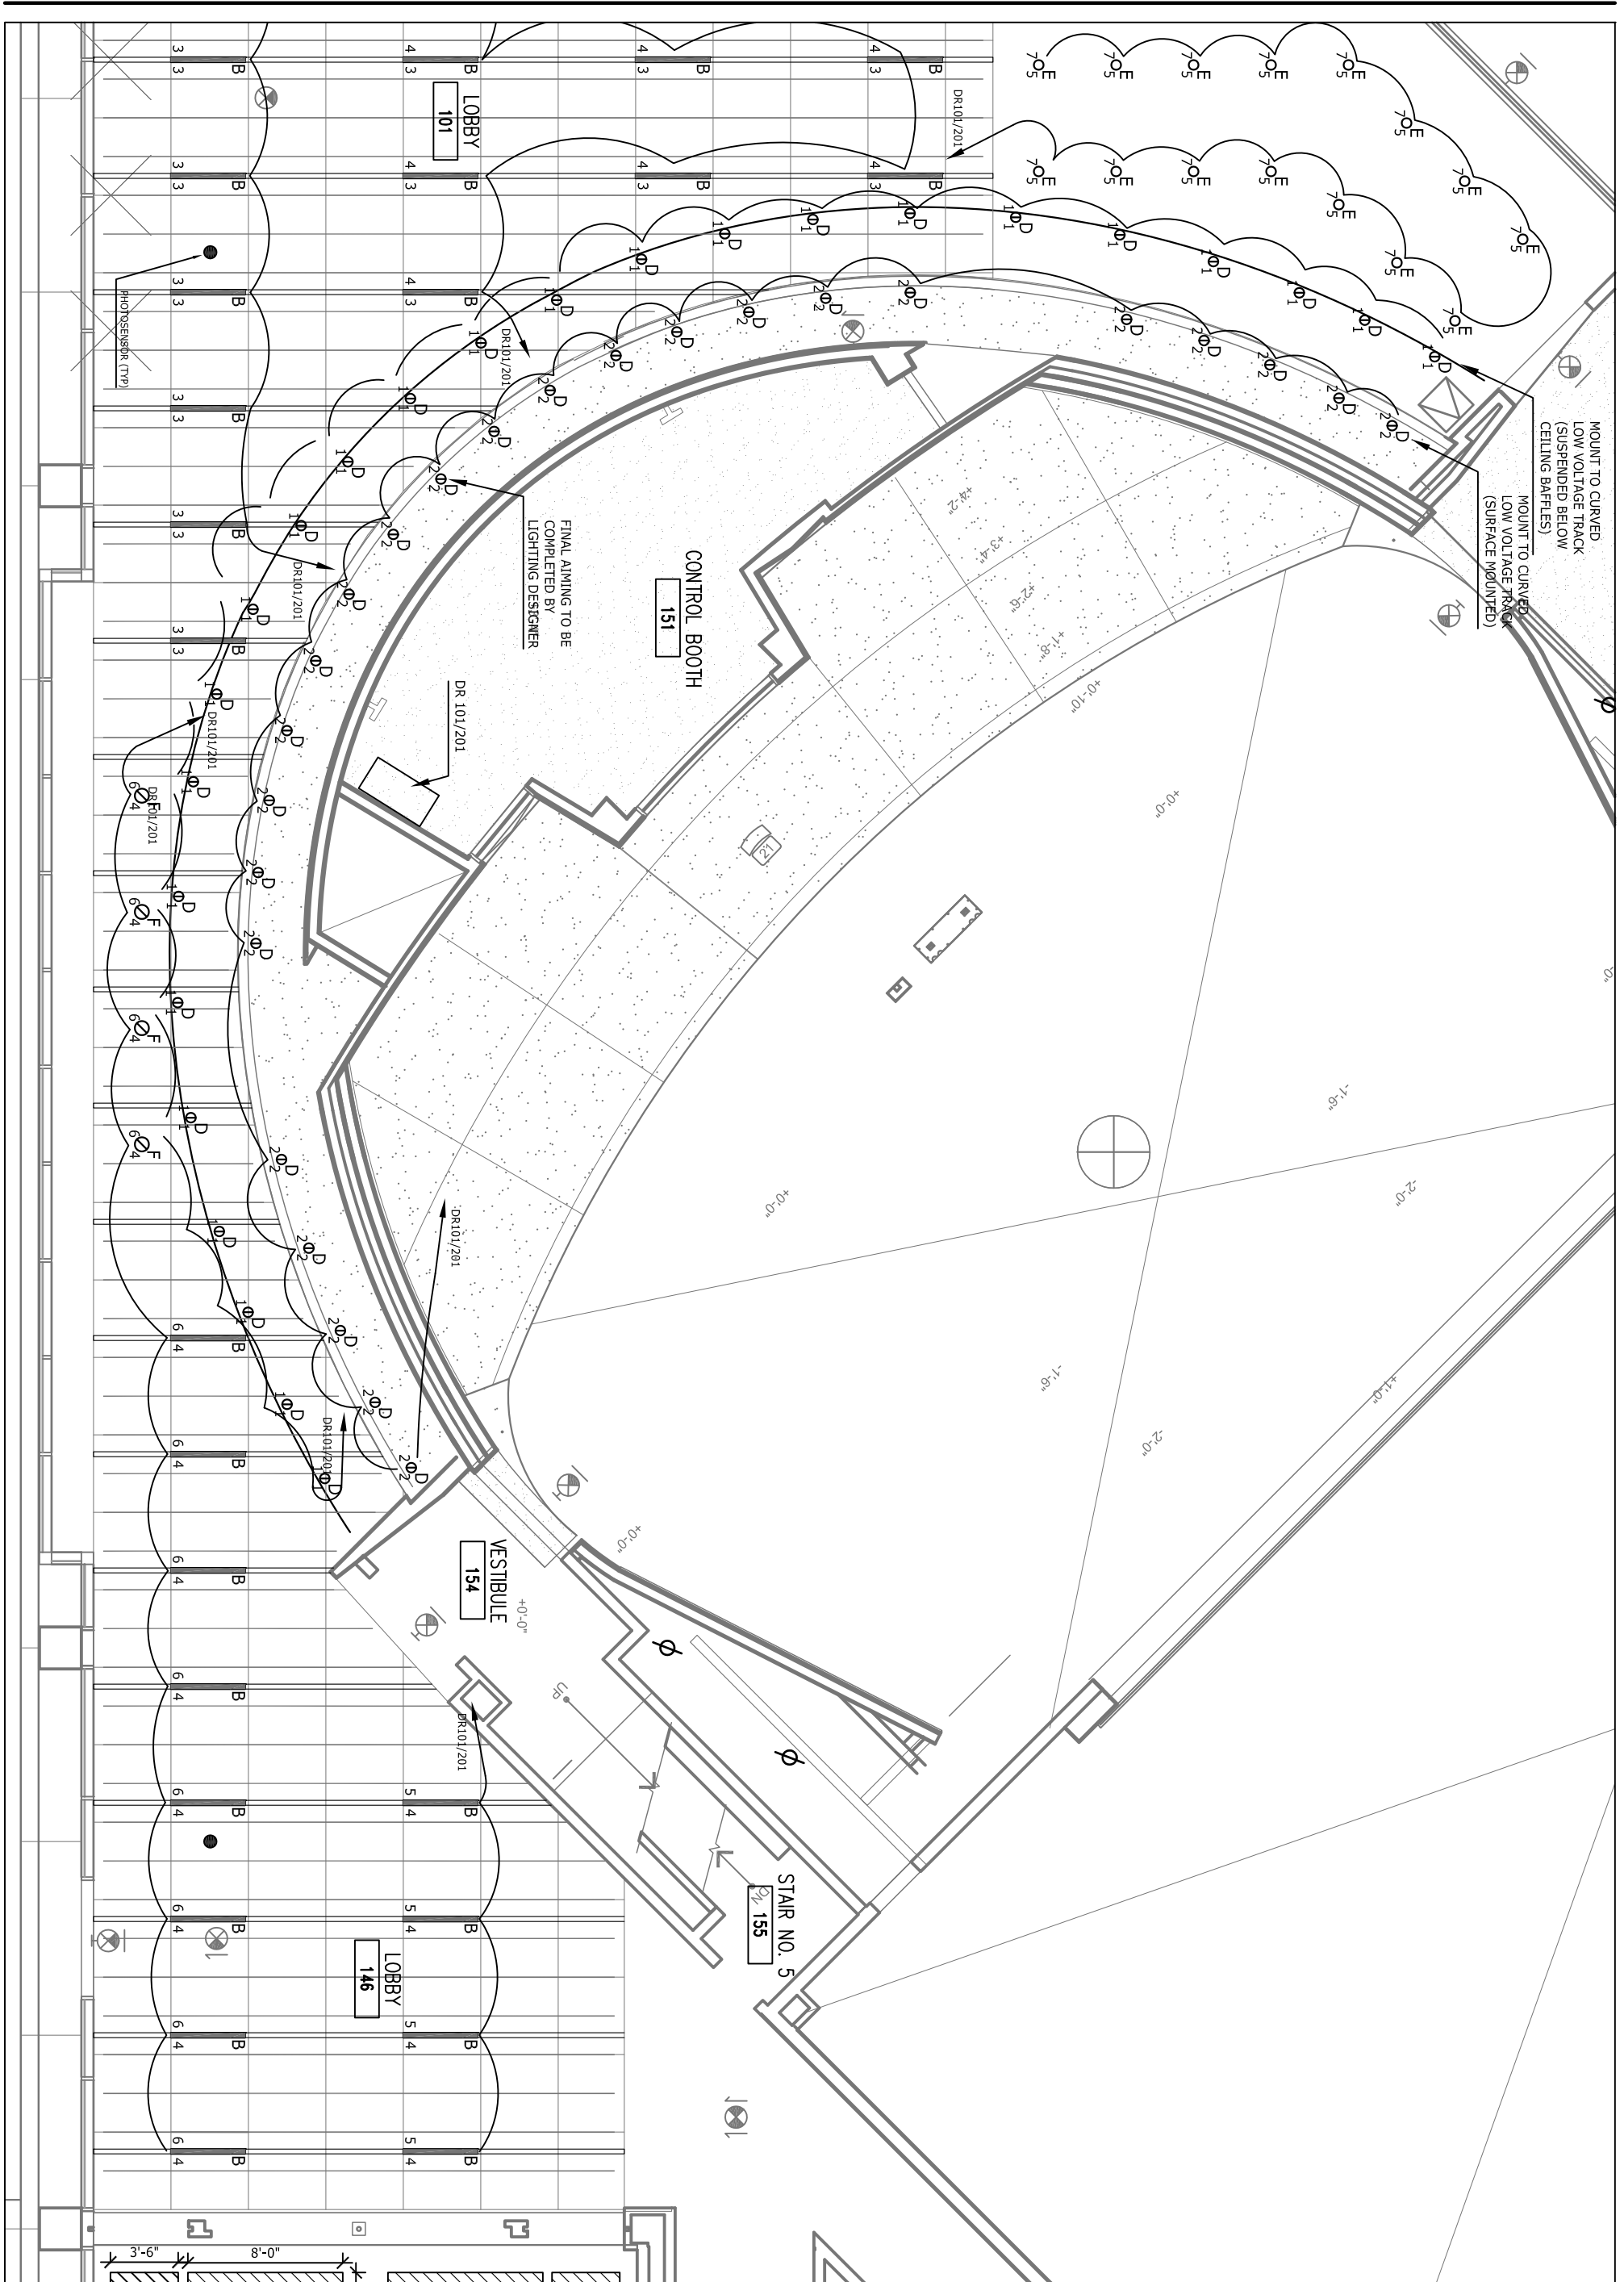

 FIRST LEVEL LIGHTING PLAN
 THE AUGUST WILSON CENTER FOR AFRICAN AMERICAN CULTURE
 SCALE: 1/8" = 1'
 PAGE: 2 OF 2



KEY:

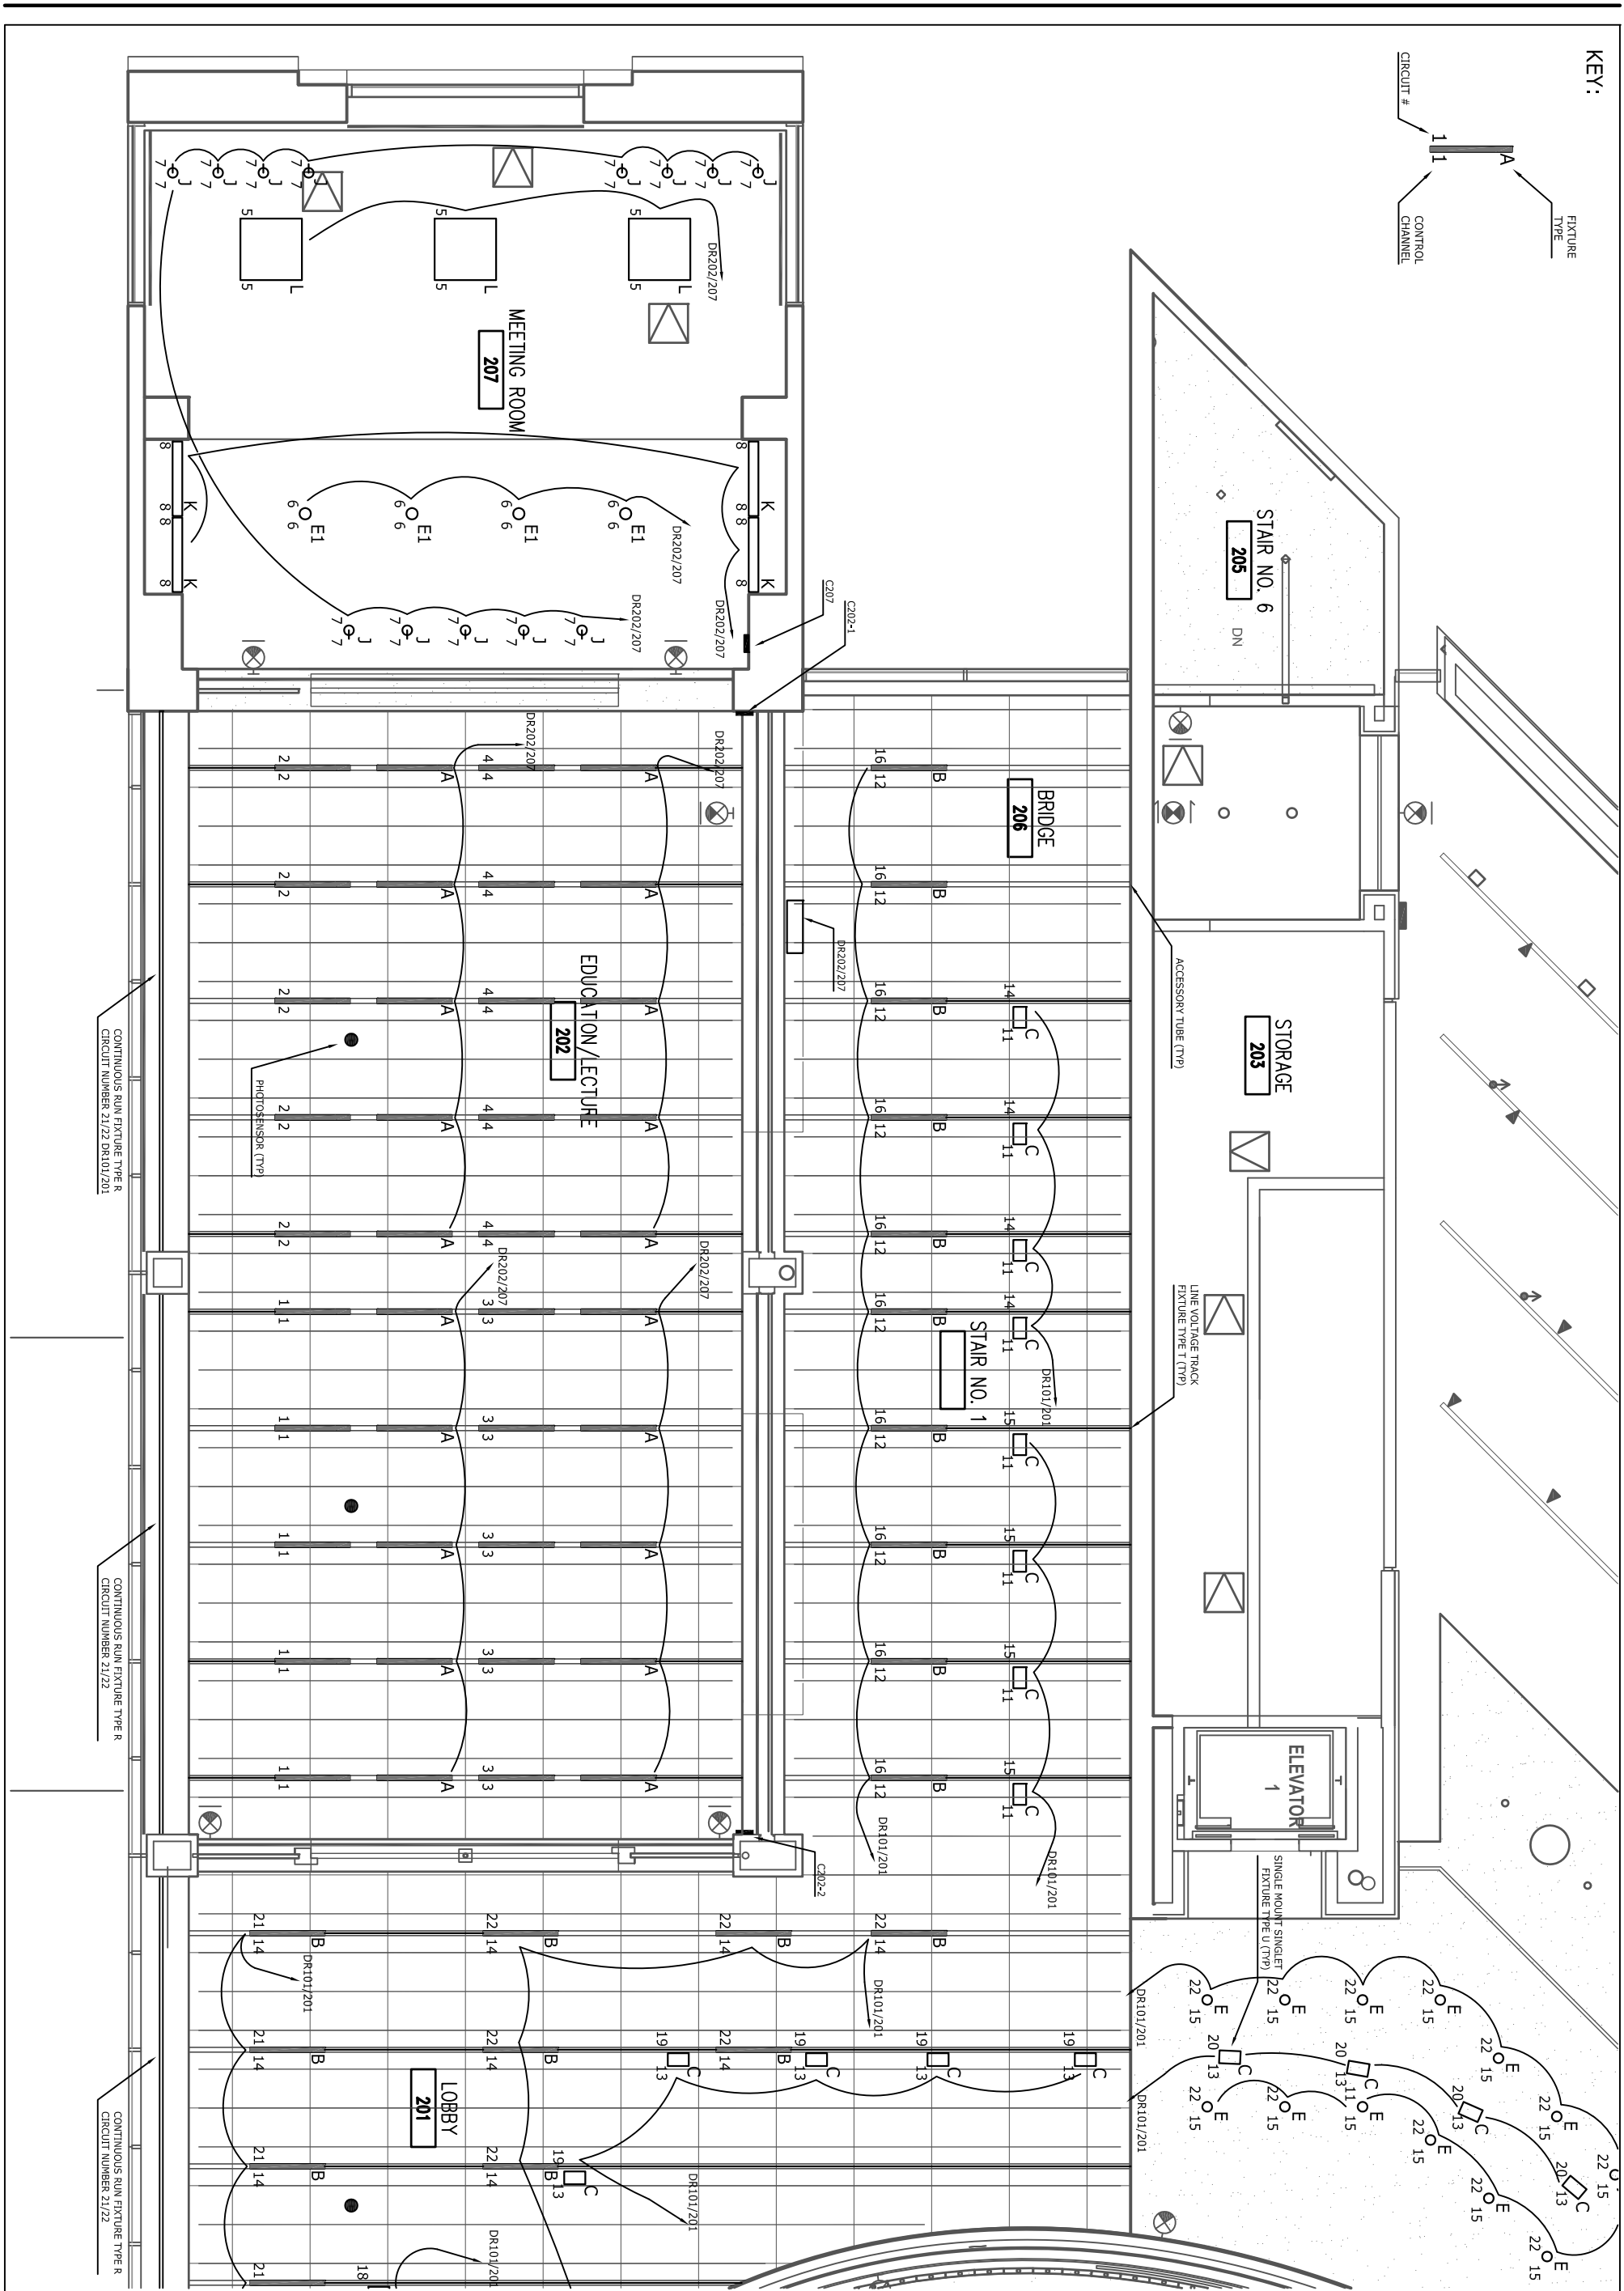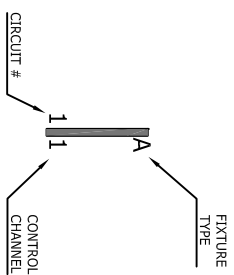

MICHAEL P. ROYER

THE PENNSYLVANIA STATE UNIVERSITY
ARCHITECTURAL ENGINEERING SENIOR THESIS
PRESENTED APRIL 16, 2008

SECOND LEVEL ELECTRICAL PLAN

THE AUGUST WILSON CENTER FOR AFRICAN AMERICAN CULTURE

SCALE: 1/8" = 1'
PAGE: 1 OF 2

