

CHANGE PROPOSAL #2
06-14-2010


NO	ISSUE	DATE
C	ISSUE FOR GMP PERMITS, PADON APPROVAL	12.08.09
1	ISSUE FOR EARLY BID	02-10-10
2	ISSUE FOR FHA CLOSING	02-17-10
3	ISSUE FOR CONSTRUCTION	03.09.10
4	ISSUE FOR FHA CLOSING PROPOSAL REQUEST #2	06-14-10

Sheet Information

Date	10/07/2009
Job Number	92801.031
Drawn	XX
Checked	XX
Approved	XX

**FIRST FLOOR PLAN -
SECTOR 'C' - PIPING**

Sheet
M-201C

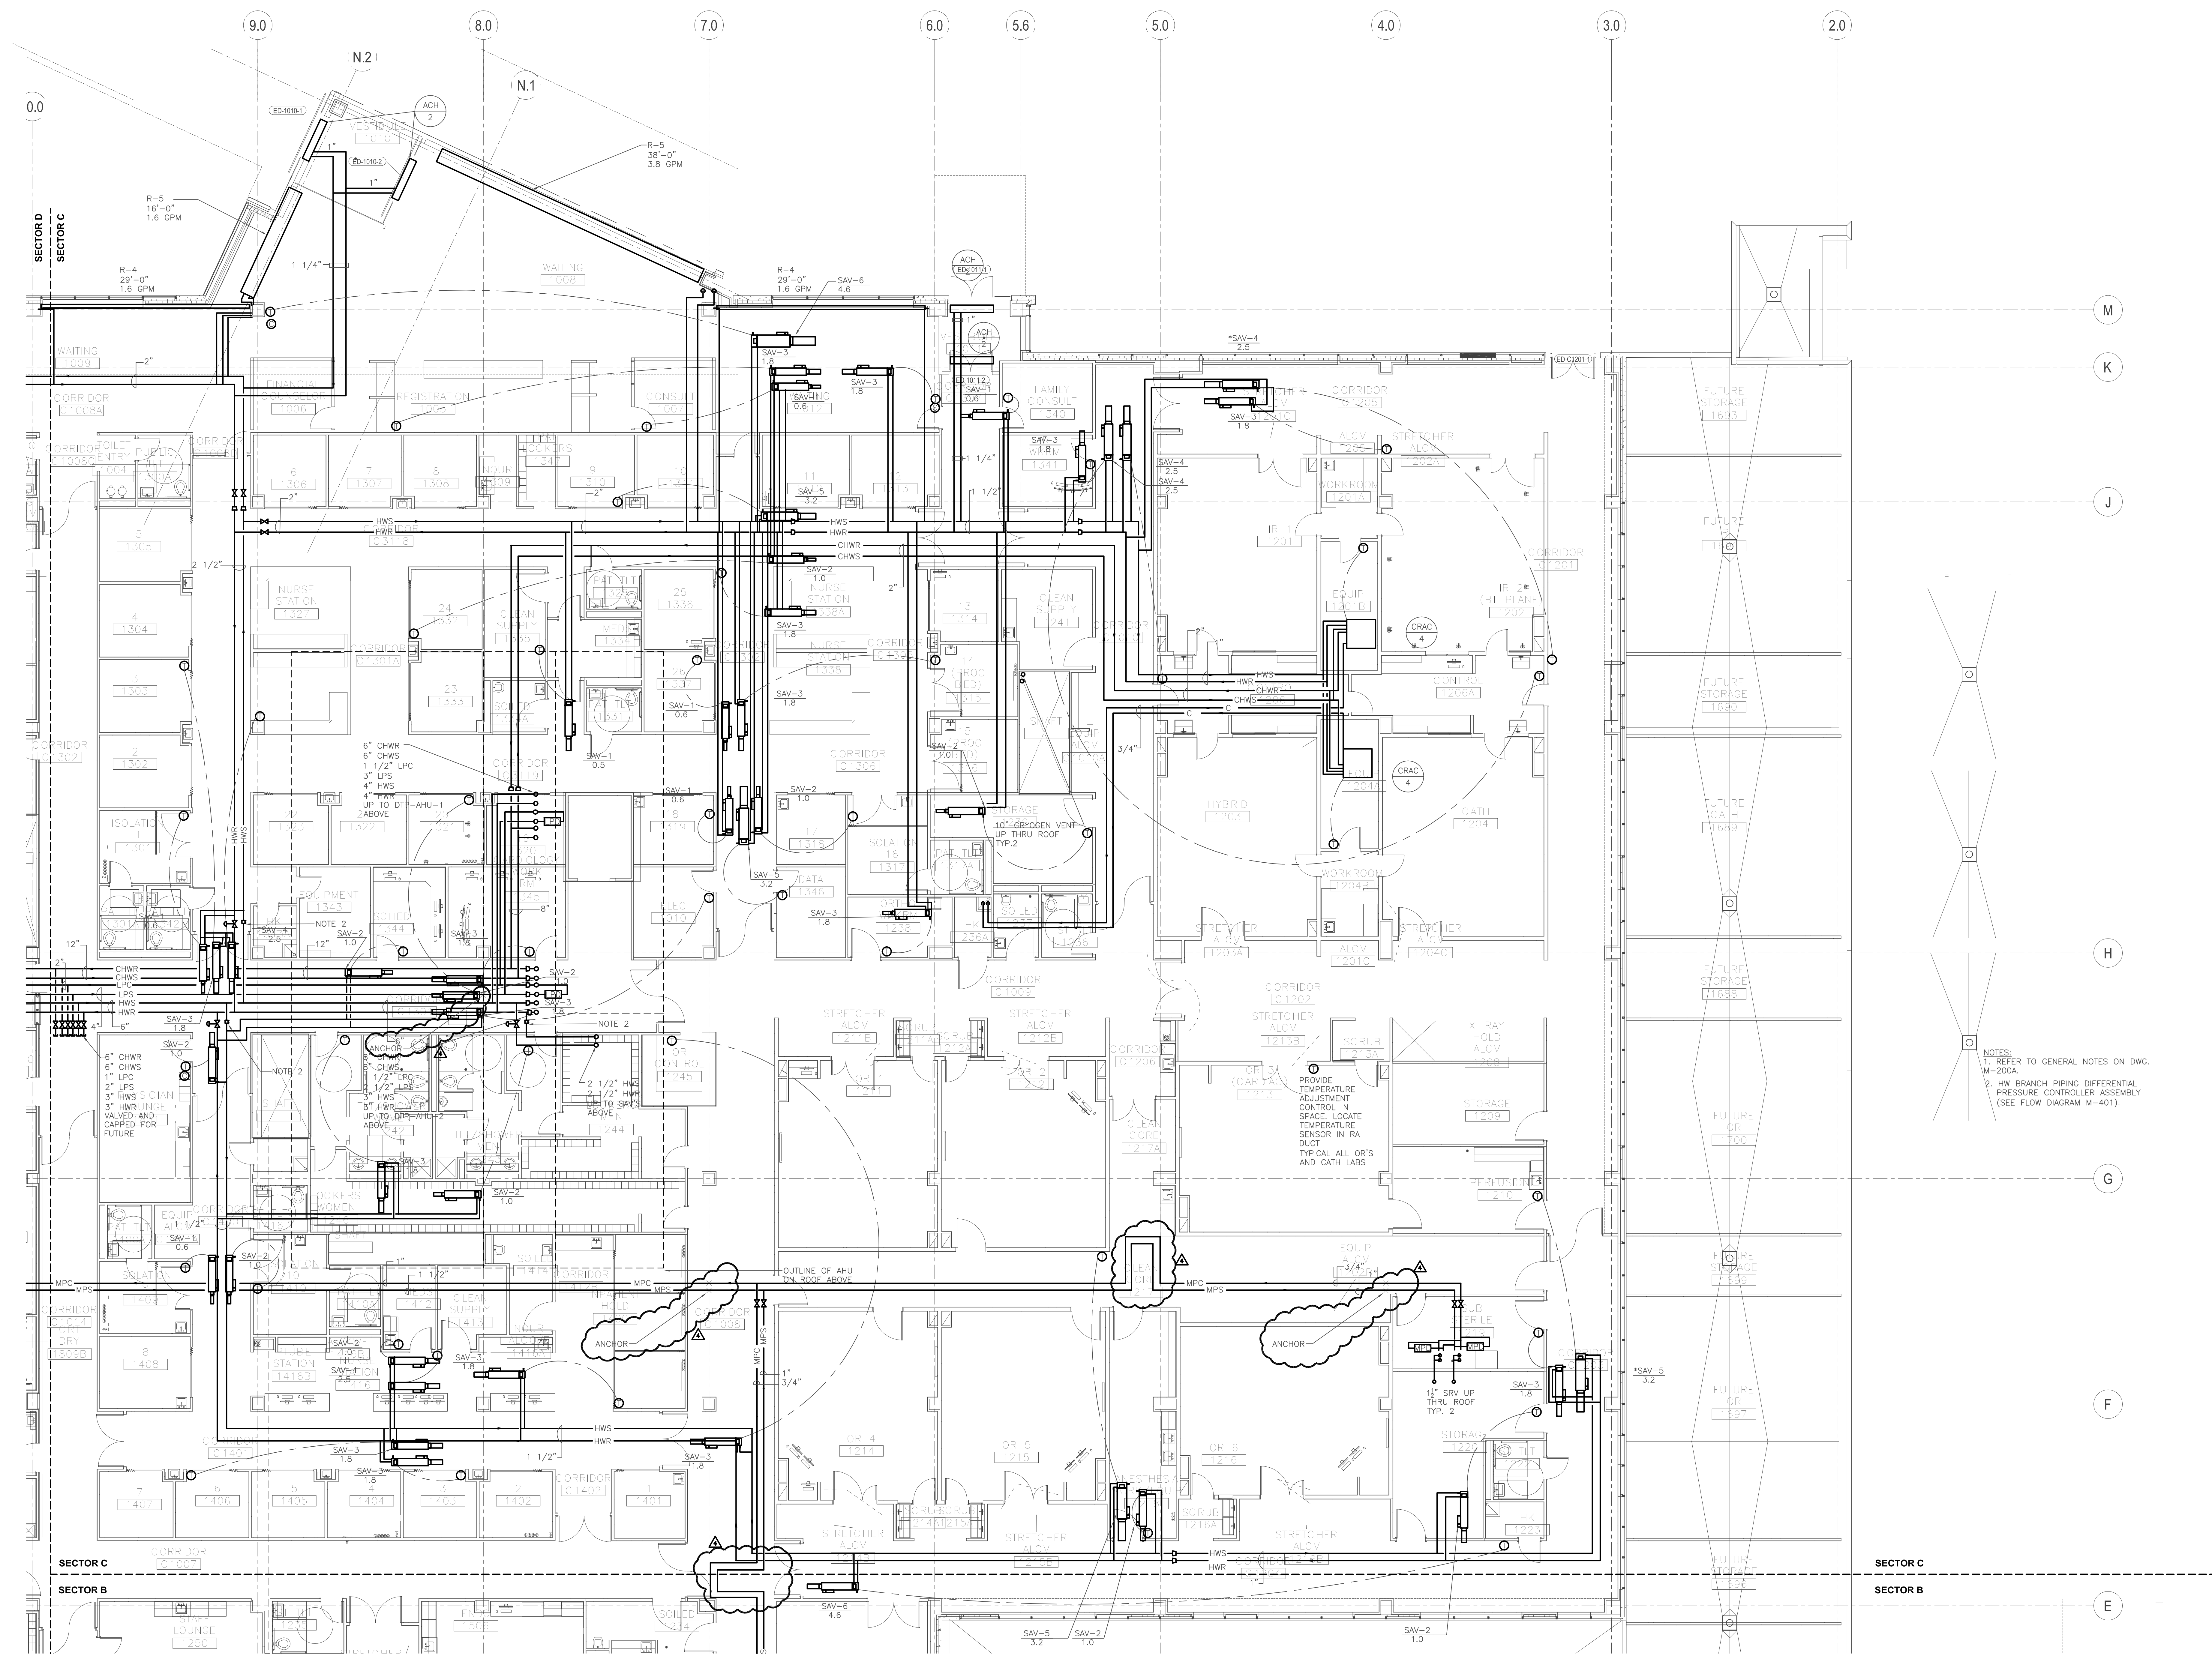

NOTES:
1. REFER TO GENERAL NOTES ON DWG. M-200A.
2. HW BRANCH PIPING DIFFERENTIAL PRESSURE CONTROLLER ASSEMBLY (SEE FLOW DIAGRAM M-401).

1 FIRST FLOOR PLAN - SECTOR 'C' - PIPING
M-201C SCALE: 1/8" = 1'-0"